


- KEY**
- | | |
|---|---|
|  | SITE RED-LINE BOUNDARY |
|  | TEMPORARY CONSTRUCTION LAYDOWN |
|  | FLUE GAS HANDLING |
|  | UTILITIES / ACCESS |
|  | TEMPORARY CAR PARK |
|  | HV TRANSFORMERS / TIE-INS |
|  | PIPING TIE-INS |
|  | CONTROL ROOM MODIFICATION |
|  | TEMPORARY WORK AREA ACCESS
(UNSHADED AREAS WITHIN RED-LINE BOUNDARY) |

KEY PLAN

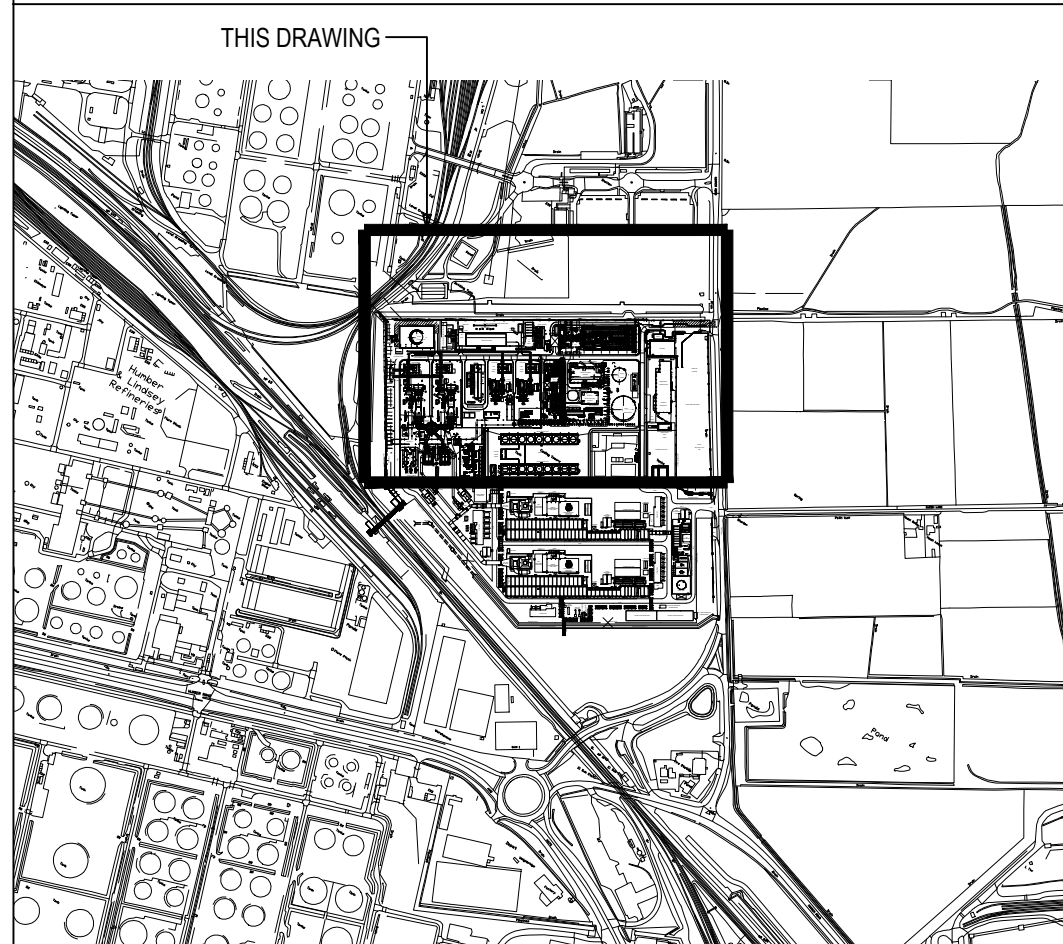

										A1 SHT	SCALE: 1:1000	ENGINEERING AND PERMIT STAMPS (As Required)	CUSTOMER	DRG TITLE			
													 	HZ-VPI-I PCC PROJECT PARAMETER / ZONING PLANNING DRAWING PLAN - SHEET 1			
1	15/02/23	FOR USE	NG	CFT	NG	CFT	AG	415000-00201-8820-01-0001	HZ-VPI-I PCC PROJECT - PARAMETER / ZONING PLANNING - KEY PLAN								
0	03/02/23	FOR USE	NG	CFT	NG	CFT	AG	415000-00201-8230-01-0002	HZ-VPI-I PCC PROJECT - PLOT PLAN								
A	04/10/22	FOR REVIEW	NG	CFT	NG	CFT	AG	415000-00201-8230-01-0001	HZ-VPI-I PCC PROJECT - SITE PLAN		WORLEY PROJECT No.						
REV	DATE	PURPOSE	DRAWN	DRAFT CHK	DESIGNED	ENG CHK	APPROVED	REF DRAWING No	REFERENCE DRAWING TITLE	415000-00201		*This drawing is prepared solely for the use of the contractual customer of Worley and Worley assumes no liability to any other party for any representations contained in this drawing.*		DRG No	415000-00201-8820-01-0002	REV	1